



ELECT. RISER DIAGRAM N.T.S.


PLUMBING RISER DIAGRAM N.T.S.

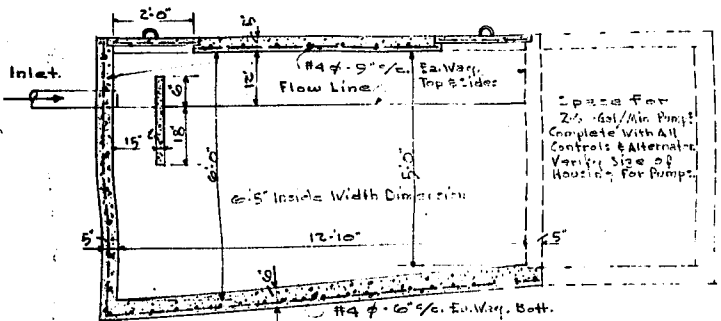


SEPTIC TANK SECTION Scale: N.T.S.

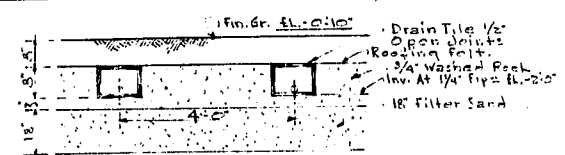


DRAIN BED DETAIL N.T.S.

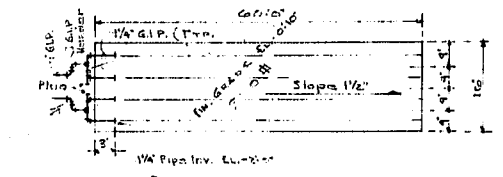

PLAN OF DRAINFIELD Scale: 1/8" = 1'-0"

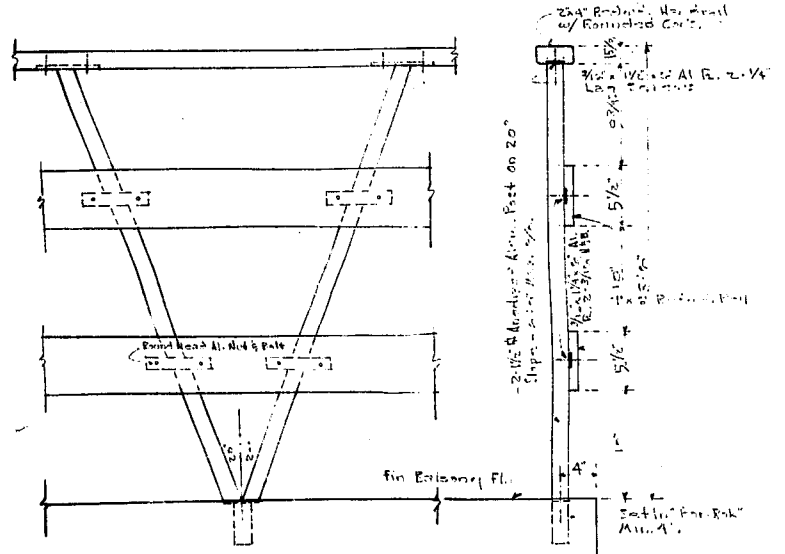

RAILING DETAIL Scale: 1/4" = 1'-0"

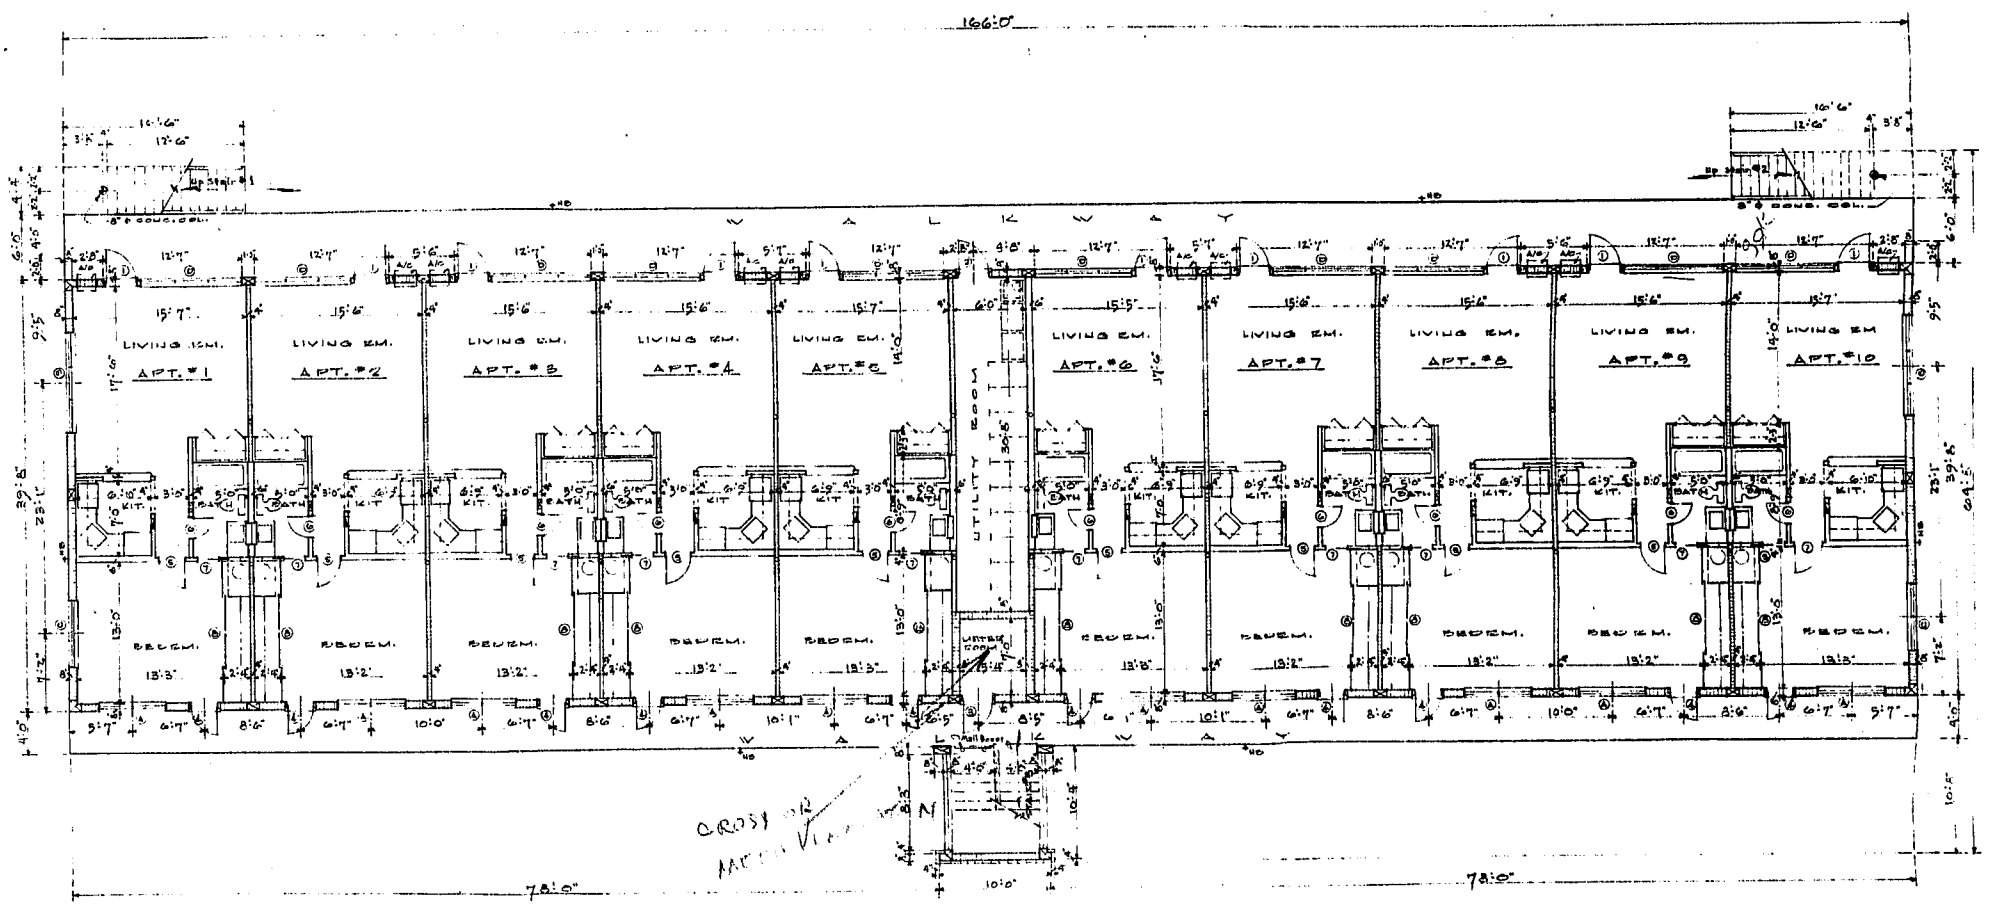

1ST FLOOR PLAN Scale: 1/8" = 1'-0"
SEE 1/2" TYPICAL APT. UNIT PLAN FOR DETAILS OF EACH APT.

20 UNIT APARTMENT FOR		REV.
J. BATTAGLIA		3/27/64
LOCATION: LOTS 12 & 13, BLOCK 7, LAKESIDE, P.R.		GEORGE F. WATKINS, A.C.
SHEET NO. 2 OF 6		DATE: MARCH 20, 1964